

Machine Tool Technology

CLASSRM
OFFICE
TOOL RM

Welding

AUTOMOTIVE TECHNOLOGY DEPARTMENT

FRONT END ALIGN
PREPARATION SHOP AREA
WELD-STOR
AUTO-STOR
MEZZANINE TOOL-STOR

PB1
PB2B
PB2A

Student Lounge

AUTO

Marine Diesel

Automotive Tech Shop

Diesel Technology Shop

114 Cardio Lab

110B Nursing Lab

112 Nursing Class

110A Nursing

104A

111 Classroom

IT

Electrician Lab 114

Electrician Class 115

Trade Lab 117

ELECT-TECH SHOP

ACREF SHOP

Maintenance

107 GED/Testing

108 Open Lab

Faculty Lounge

Student Services

106 GED

105 Nursing Class

104 Nursing Class

103 Nursing Lab

101

101A

101B

101C

101D

101E

101F


Faculty & Staff Parking

FIRST FLOOR PLAN

Fletcher Technical Community College

310 ST. CHARLES STREET - HOUMA, LOUISIANA 70360

SCALE: 1/8" = 1'

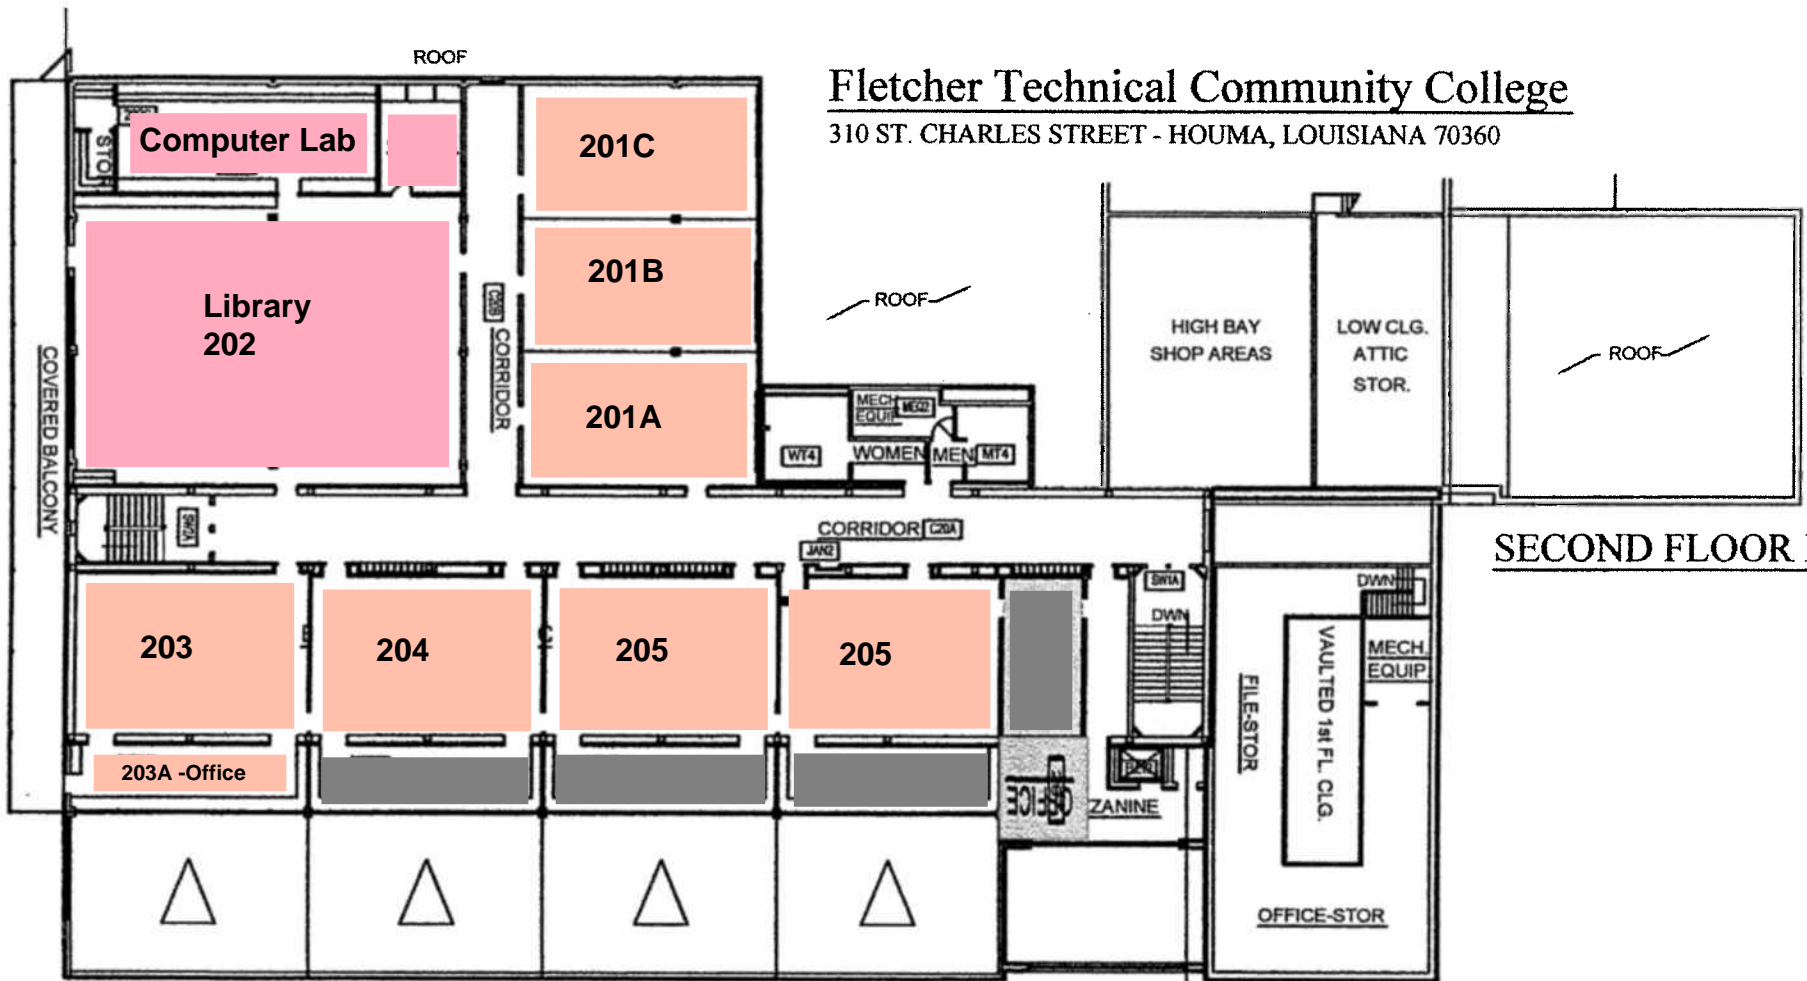

SECOND FLOOR PLAN